


WINZLER & KELLY
CONSULTING ENGINEERS
495 TESCONI CIRCLE, SANTA ROSA, CA 95401
PH (707) 523-1010 • FAX (707) 527-8679
WWW.W-AND-K.COM



CREATIVE SOLUTIONS FOR OVER 60 YEARS
EUREKA • SANTA ROSA • SAN FRANCISCO
LOS ANGELES • SAN DIEGO
GUAM • SAIPAN

CONSULTANTS

BAR IS ONE INCH ON ORIGINAL DRAWING.
0 1"
IF NOT ONE INCH ON THIS SHEET, ADJUST SCALES ACCORDINGLY

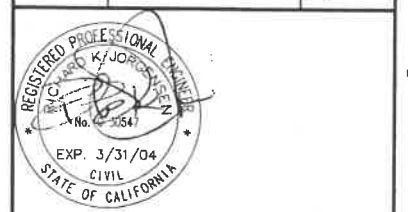

PROJECT NAME

WATER SYSTEM IMPROVEMENTS
SCHEDULE 1
(2) 500,000 GALLON STORAGE TANKS
OWNER
HIDDEN VALLEY LAKE COMMUNITY SERVICES DISTRICT

MARK	DATE	DESCRIPTION

PROJECT NO: 02-2053-04
DRAWN BY: RJF
DESIGNED BY: RKJ
CHECKED BY:

SHEET TITLE

COVER SHEET

DRAWING NUMBER

G-001
SHEET 1 OF 23

HIDDEN VALLEY LAKE COMMUNITY SERVICES DISTRICT

WATER SYSTEM IMPROVEMENTS

SCHEDULE 1

(2) 500,000 GALLON STORAGE TANKS

MARCH 2003




HIDDEN VALLEY LAKE CSD

BOARD OF DIRECTORS


- C. PETKOVICH - PRESIDENT
- T. D'AGOSTA - VICE PRESIDENT
- H. FREEMAN - FINANCE OFFICER
- J. HERROD - DIRECTOR
- J. SHARPEN - DIRECTOR

PLANS AND SPECIFICATIONS APPROVED BY THE BOARD OF DIRECTORS OF THE HIDDEN VALLEY LAKE COMMUNITY SERVICES DISTRICT, COUNTY OF LAKE, STATE OF CALIFORNIA, THIS _____ DAY OF _____ 2003.


SIGNED:
MEL AUST, General Manager

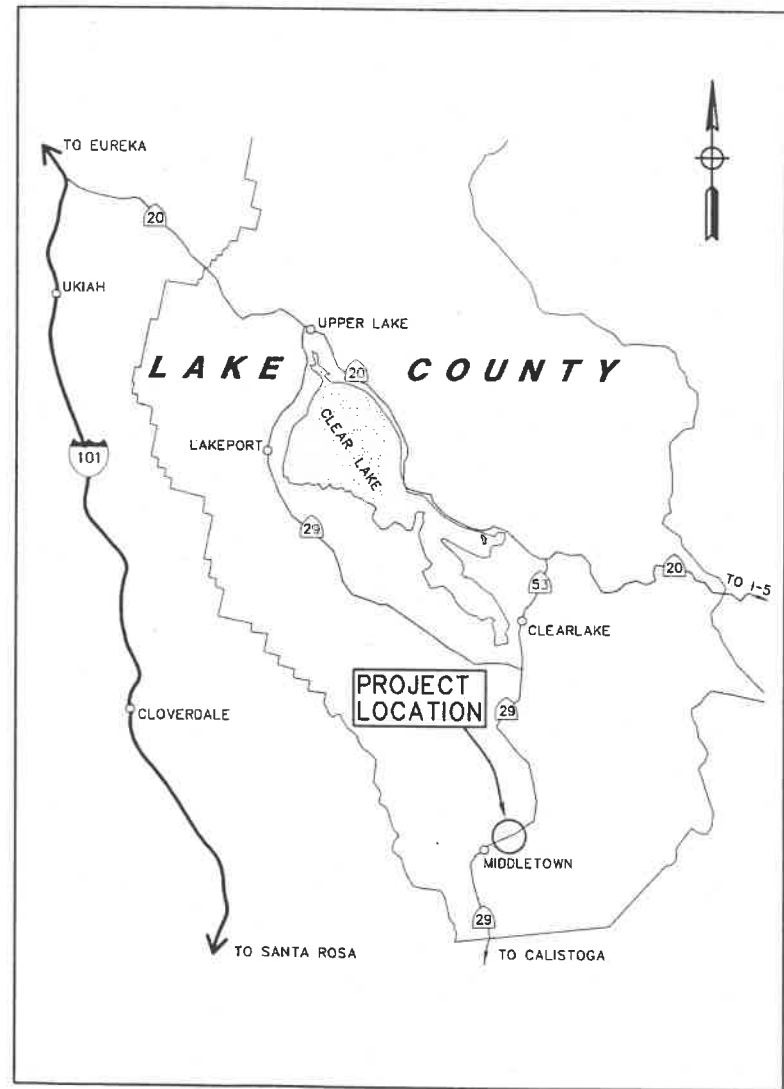

LOCATION MAP

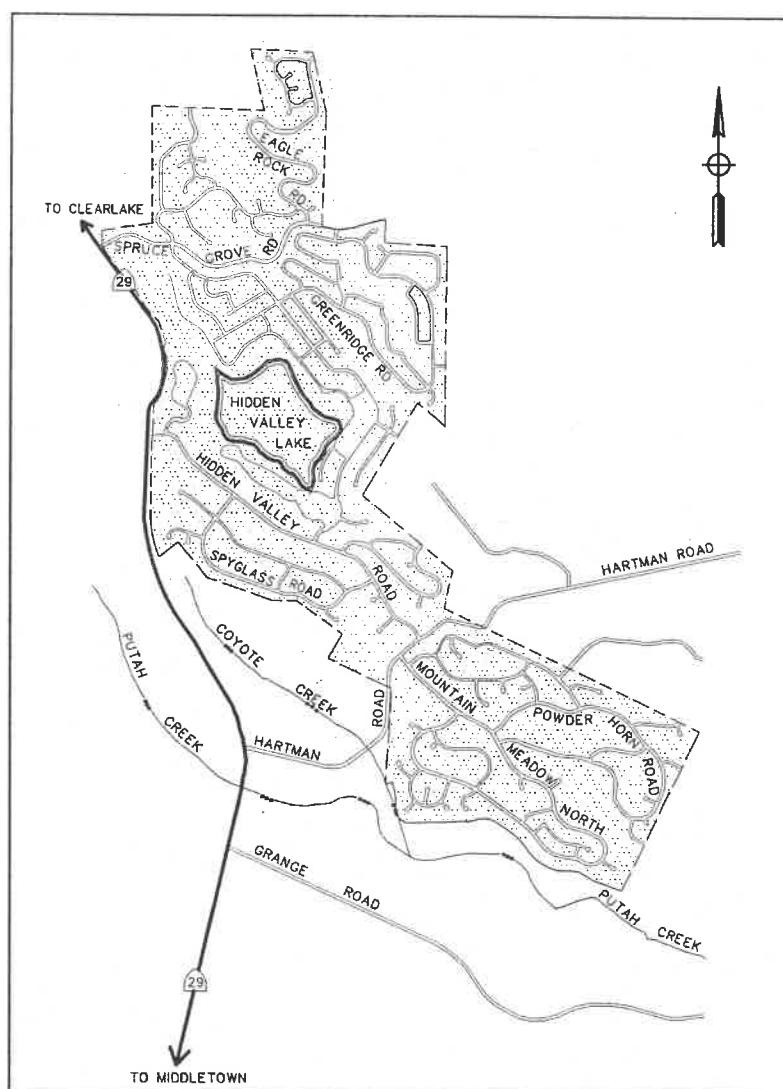

VICINITY MAP

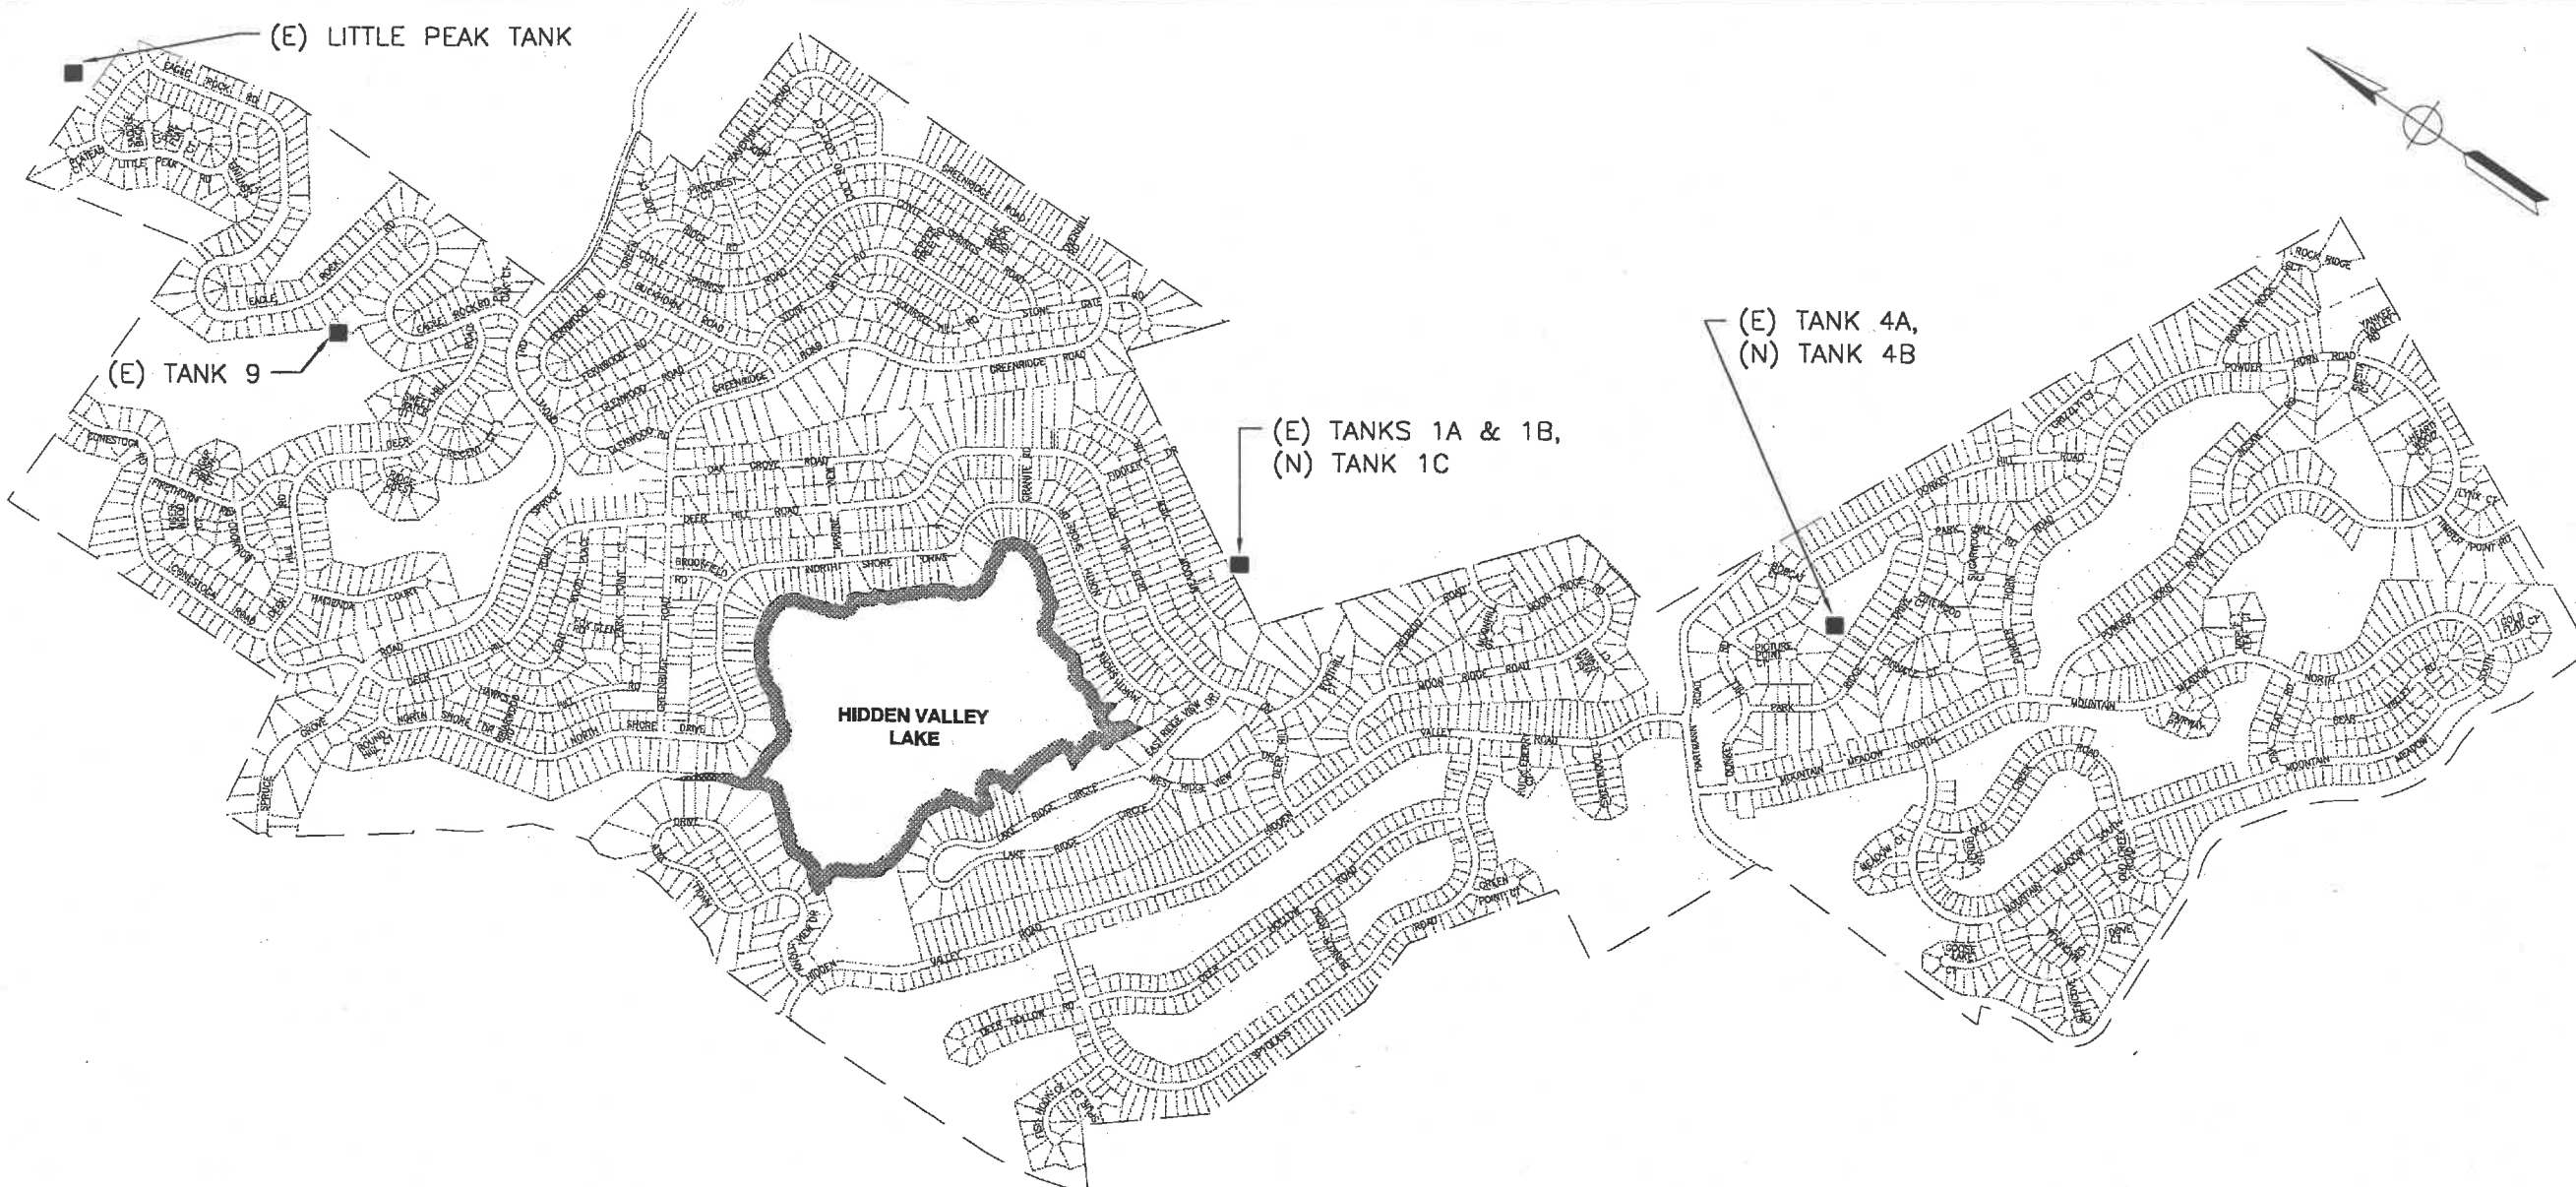

SITE PLAN
SCALE: 1"=700'

INDEX TO SHEETS

Sht	Dwg No.	Sheet Title	Sht	Dwg No.	Sheet Title
GENERAL			STRUCTURAL		
1.	G-001	COVER SHEET	17.	S-001	GENERAL STRUCTURAL NOTES & TYPICAL DETAILS
2.	G-002	SITE PLAN & INDEX OF DRAWINGS	18.	S-101	TANKS 1C & 4B, FOUNDATION PLAN & DETAILS
3.	G-003	ABBREVIATIONS, SYMBOLS & LEGEND	ELECTRICAL		
CIVIL			19.	E-001	ELECTRICAL LEGEND
4.	C-001	GENERAL CIVIL NOTES	20.	E-110	TANKS 1A, 1B & 1C, ELECTRICAL SITE PLAN
5.	C-110	TANKS 1A, 1B & 1C, DEMOLITION & CLEARING PLAN	21.	E-120	TANK 9 & LITTLE PEAK, ELECTRICAL SITE PLAN
6.	C-111	TANKS 1A, 1B & 1C, GRADING PLAN	22.	E-140	TANKS 4A & 4B, ELECTRICAL SITE PLAN
7.	C-112	TANKS 1A, 1B & 1C, ACCESS ROAD GRADING PLAN	23.	E-501	DETAILS
8.	C-120	TANKS 1A, 1B & 1C, PIPING PLAN			
9.	C-140	TANKS 4A & 4B, CLEARING & GRADING PLAN			
10.	C-141	TANKS 4A & 4B, PIPING PLAN			
11.	C-501	TANK SECTION & DETAILS			
12.	C-502	TANK DETAILS - 1			
13.	C-503	TANK DETAILS - 2			
14.	C-550	DETAILS - 1			
15.	C-551	DETAILS - 2			
16.	C-552	DETAILS - 3			

WINZLER & KELLY
CONSULTING ENGINEERS
495 TESCONI CIRCLE, SANTA ROSA, CA 95401
PH (707) 523-1010 ♦ FAX (707) 527-8679
WWW.W-AND-K.COM

CREATIVE SOLUTIONS FOR OVER 60 YEARS
EUREKA ♦ SANTA ROSA ♦ SAN FRANCISCO
LOS ANGELES ♦ SAN DIEGO
GUAM ♦ SAIPAN

CONSULTANTS

BAR IS ONE INCH ON ORIGINAL DRAWING.
0 1" 1"
IF NOT ONE INCH ON THIS SHEET, ADJUST SCALES ACCORDINGLY



PROJECT NAME
WATER SYSTEM IMPROVEMENTS SCHEDULE 1 (2) 500,000 GALLON STORAGE TANKS
OWNER
HIDDEN VALLEY LAKE COMMUNITY SERVICES DISTRICT

MARK	DATE	DESCRIPTION

PROJECT NO: **02-2053-04**
DRAWN BY: **RJF**
DESIGNED BY: **RKJ**
CHECKED BY:

SHEET TITLE
SITE PLAN & INDEX OF DRAWINGS

DRAWING NUMBER
G-002
SHEET **2** OF **23**

HIDDEN VALLEY LAKE COMMUNITY SERVICES DISTRICT

WATER SYSTEM IMPROVEMENTS


SCHEDULE 2 BOOSTER PUMP STATION REPLACEMENTS

MARCH 2003

WINZLER & KELLY
CONSULTING ENGINEERS
495 TESCONI CIRCLE, SANTA ROSA, CA 95401
PH (707) 523-1010 ♦ FAX (707) 527-8679
WWW.W-AND-K.COM

CONSULTANTS

BAR IS ONE INCH ON ORIGINAL DRAWING.
IF NOT ONE INCH ON THIS SHEET, ADJUST SCALES ACCORDINGLY

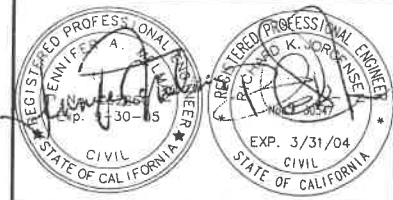

PROJECT NAME

WATER SYSTEM
IMPROVEMENTS
SCHEDULE 2
BOOSTER PUMP STATION
REPLACEMENTS
OWNER
HIDDEN VALLEY LAKE
COMMUNITY SERVICES
DISTRICT

MARK DATE DESCRIPTION

PROJECT NO: 02-2053-04
DRAWN BY: RJF
DESIGNED BY: JM
CHECKED BY:


SHEET TITLE

COVER SHEET


DRAWING NUMBER

G-001

SHEET 1 OF 41

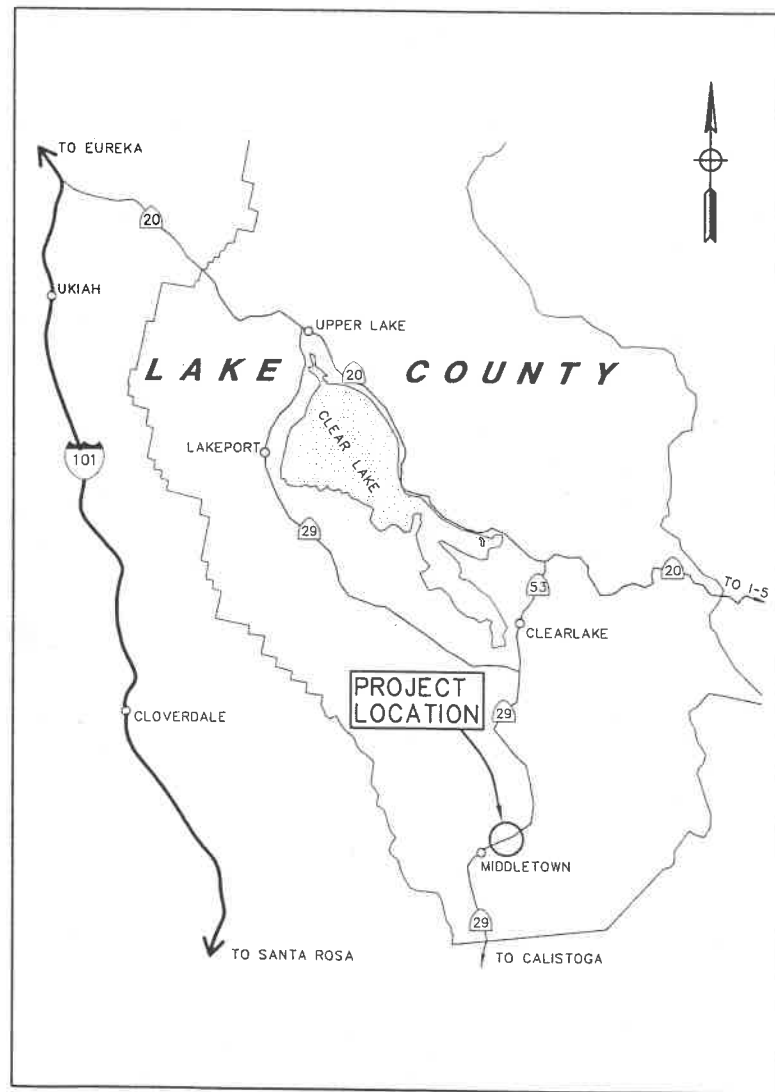

LOCATION MAP

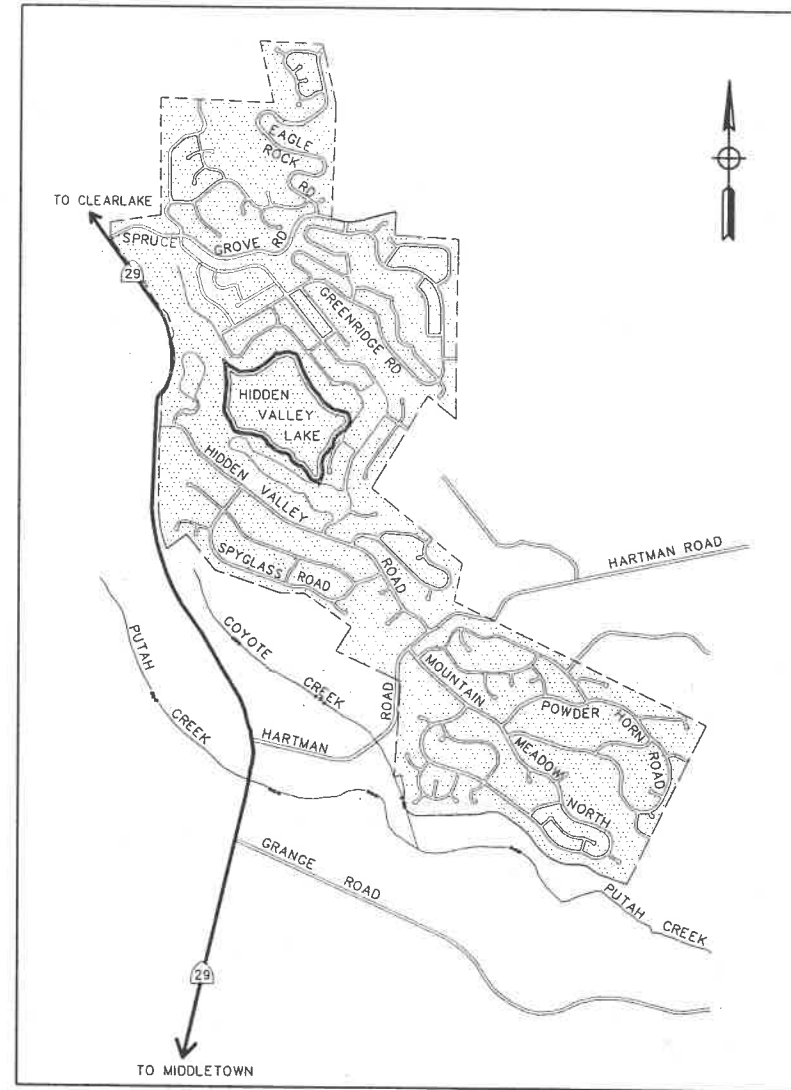

VICINITY MAP



HIDDEN VALLEY LAKE CSD BOARD OF DIRECTORS

- C. PETKOVICH - PRESIDENT
- T. D'AGOSTA - VICE PRESIDENT
- H. FREEMAN - FINANCE OFFICER
- J. HERROD - DIRECTOR
- J. SHARPEN - DIRECTOR

PLANS AND SPECIFICATIONS APPROVED BY THE BOARD OF DIRECTORS
OF THE HIDDEN VALLEY LAKE COMMUNITY SERVICES DISTRICT, COUNTY OF LAKE,
STATE OF CALIFORNIA, THIS _____ DAY OF _____ 2003.

SIGNED:
MEL AUST, General Manager

WINZLER & KELLY
CONSULTING ENGINEERS

495 TESCONI CIRCLE, SANTA ROSA, CA 95401
PH (707) 523-1010 • FAX (707) 527-8679
WWW.W-AND-K.COM



CREATIVE SOLUTIONS FOR OVER 60 YEARS
EUREKA • SANTA ROSA • SAN FRANCISCO
LOS ANGELES • SAN DIEGO
GUAM • SAIPAN


CONSULTANTS

BAR IS ONE INCH ON
ORIGINAL DRAWING.
0 1"
IF NOT ONE INCH ON
THIS SHEET, ADJUST
SCALES ACCORDINGLY



PROJECT NAME

**WATER SYSTEM
IMPROVEMENTS
SCHEDULE 2
BOOSTER PUMP STATION
REPLACEMENTS**
OWNER
**HIDDEN VALLEY LAKE
COMMUNITY SERVICES
DISTRICT**

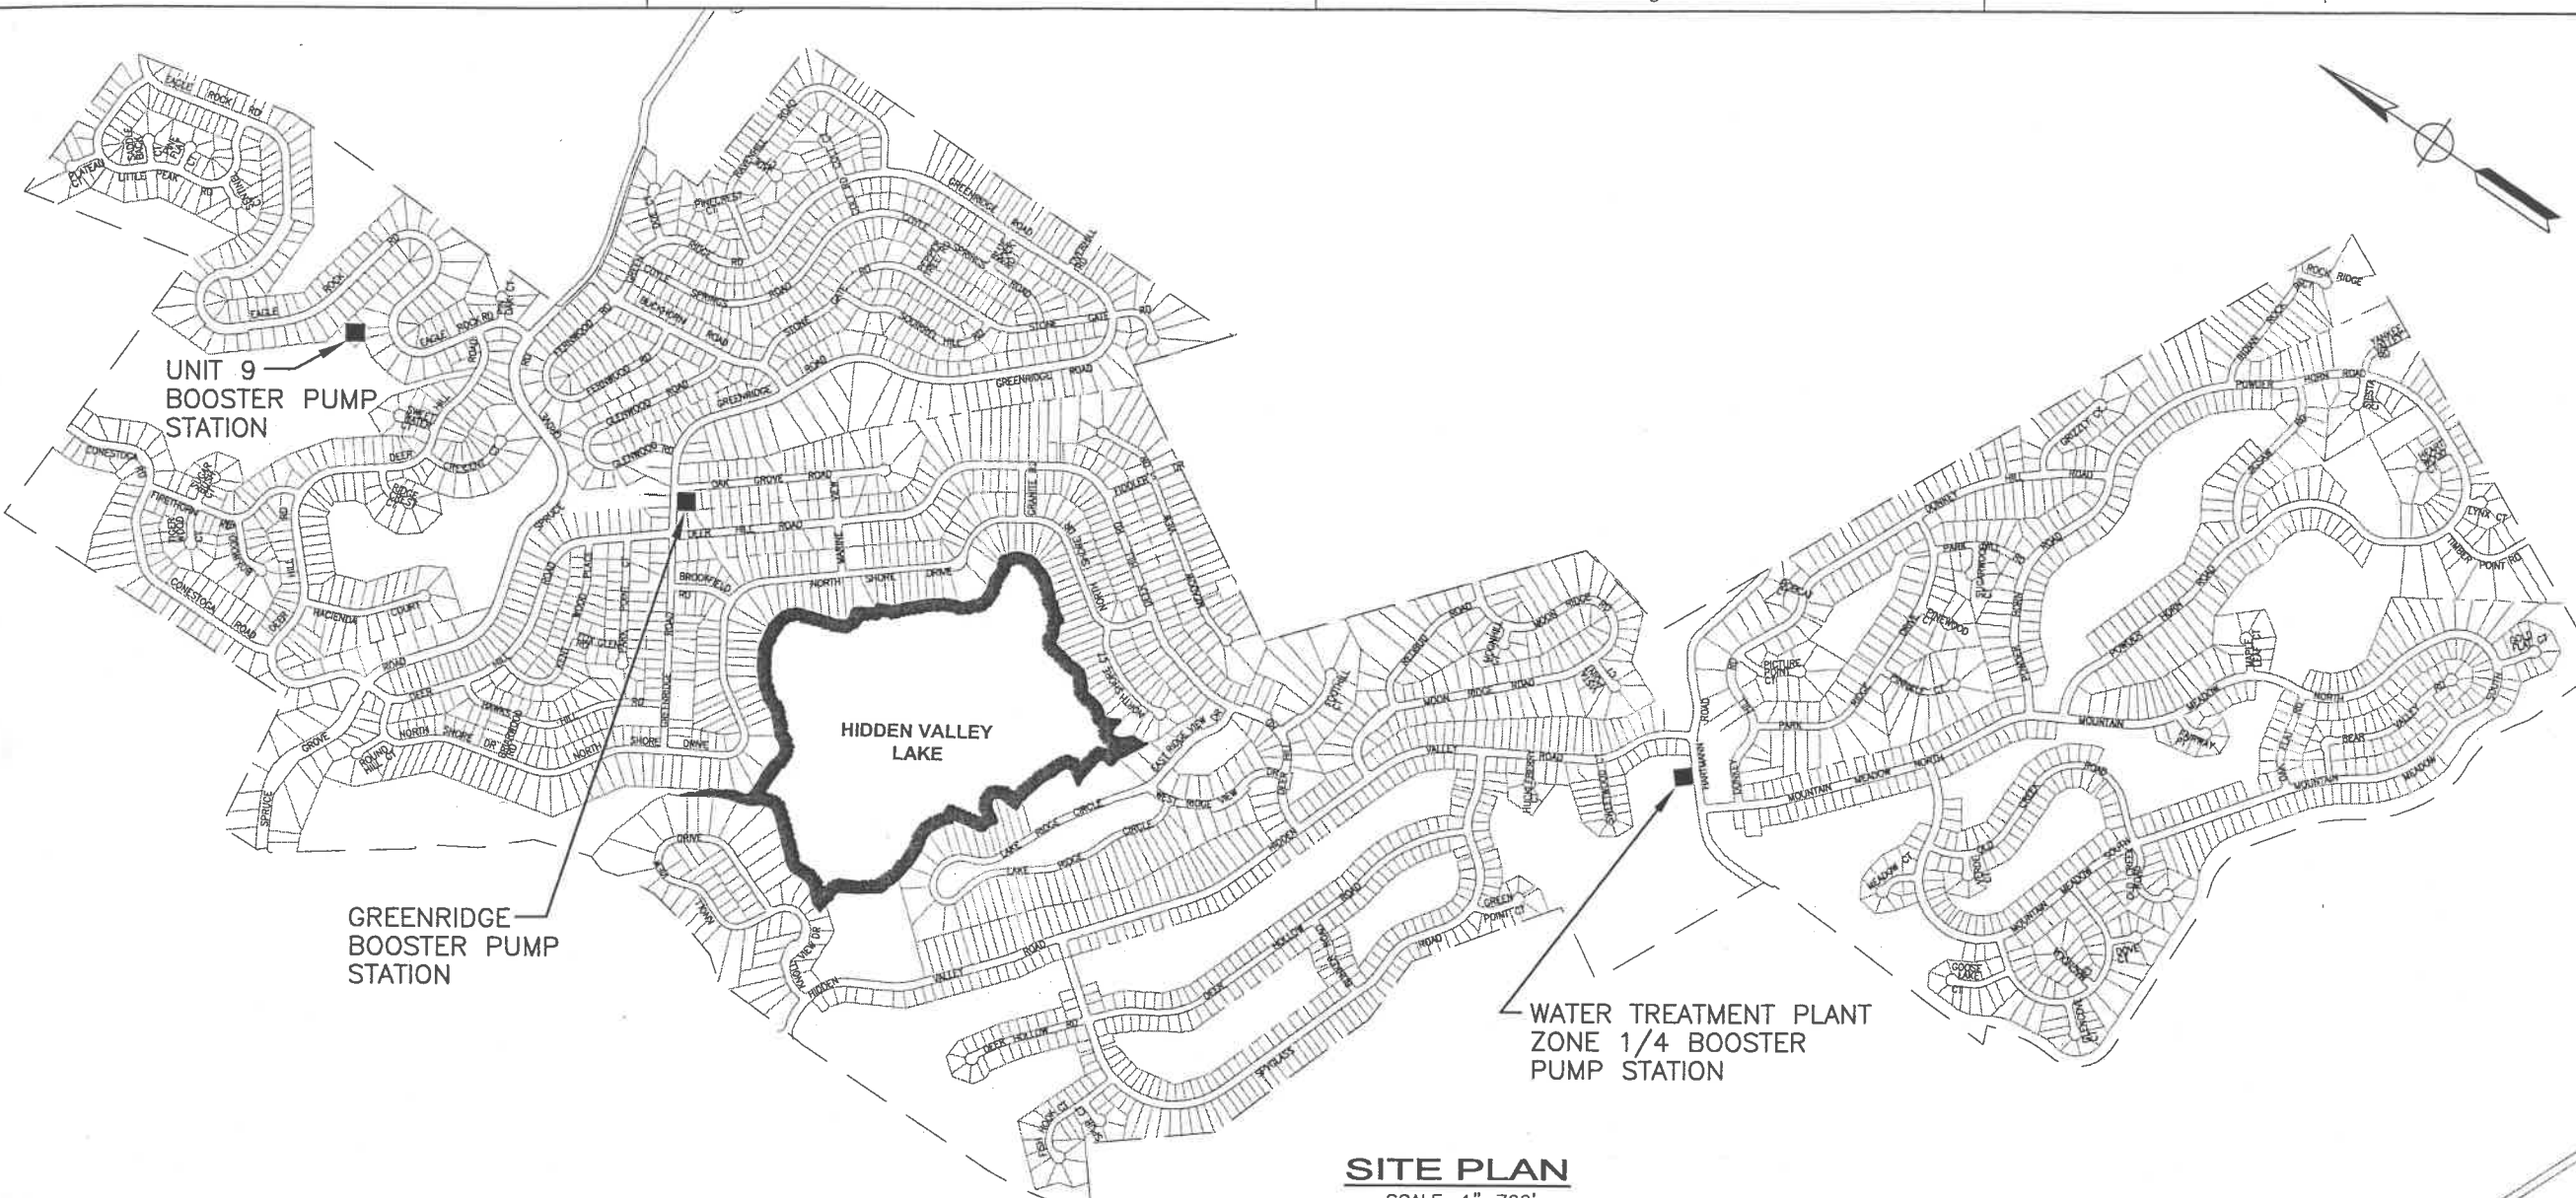

SITE PLAN
SCALE: 1"=700'

INDEX TO SHEETS

Sht	Dwg No.	Sheet Title
<u>GENERAL</u>		
1.	G-001	COVER SHEET
2.	G-002	SITE PLAN & INDEX OF DRAWINGS
3.	G-003	ABBREVIATIONS, SYMBOLS & LEGEND
<u>DEMOLITION</u>		
4.	D-101	ZONE 1/4 BPS & GREENRIDGE BPS, DEMOLITION PLAN
5.	D-102	UNIT 9 BPS, DEMOLITION PLAN
<u>CIVIL</u>		
6.	C-001	GENERAL CIVIL NOTES
7.	C-120	ZONE 1/4 BPS, GRADING PLAN
8.	C-121	ZONE 1/4 BPS, YARD PIPING PLAN
9.	C-130	GREENRIDGE BPS, GRADING PLAN
10.	C-131	GREENRIDGE BPS, YARD PIPING PLAN
11.	C-501	DETAILS - 1
12.	C-502	DETAILS - 2
<u>STRUCTURAL</u>		
13.	S-001	GENERAL STRUCTURAL NOTES AND TYPICAL DETAILS
14.	S-101	ZONE 1/4 BPS, FLOOR/FOUNDATION PLAN
15.	S-102	ZONE 1/4 BPS, ROOF/ROOF FRAMING PLAN
16.	S-103	GREENRIDGE BPS, FLOOR/FOUNDATION PLAN

Sht	Dwg No.	Sheet Title
<u>STRUCTURAL</u>		
17.	S-104	GREENRIDGE BPS, ROOF/ROOF FRAMING PLAN
18.	S-201	ZONE 1/4 BPS, BUILDING EXTERIOR ELEVATIONS
19.	S-202	GREENRIDGE BPS, BUILDING EXTERIOR ELEVATIONS
20.	S-501	DETAILS-1
21.	S-502	DETAILS-2
<u>MECHANICAL</u>		
22.	M-120	ZONE 1/4 BPS, PLAN
23.	M-320	ZONE 1/4 BPS, SECTIONS
24.	M-321	ZONE 1/4 BPS, SECTIONS
25.	M-130	GREENRIDGE BPS, PLAN
26.	M-330	GREENRIDGE BPS, SECTIONS
27.	M-140	UNIT 9 BPS, PLAN & SECTION
28.	M-501	DETAILS - 1
29.	M-502	DETAILS - 2

Sht	Dwg No.	Sheet Title
<u>ELECTRICAL</u>		
30.	E-001	ELECTRICAL LEGEND
31.	E-120	ZONE 1/4 BPS, SITE PLAN
32.	E-220	ZONE 1/4 BPS, POWER PLAN
33.	E-221	ZONE 1/4 BPS, LIGHTING PLAN
34.	E-620	ZONE 1/4 BPS, MCC ELEVATION
35.	E-621	ZONE 1/4 BPS, SCHEDULES
36.	E-130	GREENRIDGE BPS, SITE PLAN
37.	E-230	GREENRIDGE BPS, POWER & LIGHTING PLAN
38.	E-630	GREENRIDGE BPS, MCC ELEVATION & SCHEDULES
39.	E-240	UNIT 9 BPS, POWER PLAN
40.	E-640	UNIT 9 BPS, MCC ELEVATION & SCHEDULES
41.	E-501	DETAILS

MARK DATE DESCRIPTION

PROJECT NO: **02-2053-04**
DRAWN BY: **RJF**
DESIGNED BY: **JM**
CHECKED BY:

SHEET TITLE

**SITE PLAN
& INDEX OF DRAWINGS**

DRAWING NUMBER

G-002
SHEET **2** OF **41**

HIDDEN VALLEY LAKE COMMUNITY SERVICES DISTRICT

WATER SYSTEM IMPROVEMENTS

SCHEDULE 3

PRV REPLACEMENTS

MARCH 2003

WINZLER & KELLY
CONSULTING ENGINEERS
495 TESCONI CIRCLE, SANTA ROSA, CA 95401
PH (707) 523-1010 • FAX (707) 527-8679
WWW.W-AND-K.COM



CREATIVE SOLUTIONS FOR OVER 60 YEARS
EUREKA • SANTA ROSA • SAN FRANCISCO
LOS ANGELES • SAN DIEGO
GUAM • SAIPAN

CONSULTANTS

BAR IS ONE INCH ON ORIGINAL DRAWING.
0 1"
IF NOT ONE INCH ON THIS SHEET, ADJUST SCALES ACCORDINGLY



PROJECT NAME

WATER SYSTEM
IMPROVEMENTS
SCHEDULE 3
PRV REPLACEMENTS

OWNER
HIDDEN VALLEY LAKE
COMMUNITY SERVICES
DISTRICT

MARK	DATE	DESCRIPTION

PROJECT NO: 02-2053-04
DRAWN BY: RJF
DESIGNED BY: JM
CHECKED BY:


SHEET TITLE

COVER SHEET


DRAWING NUMBER

G-001

SHEET 1 OF 8

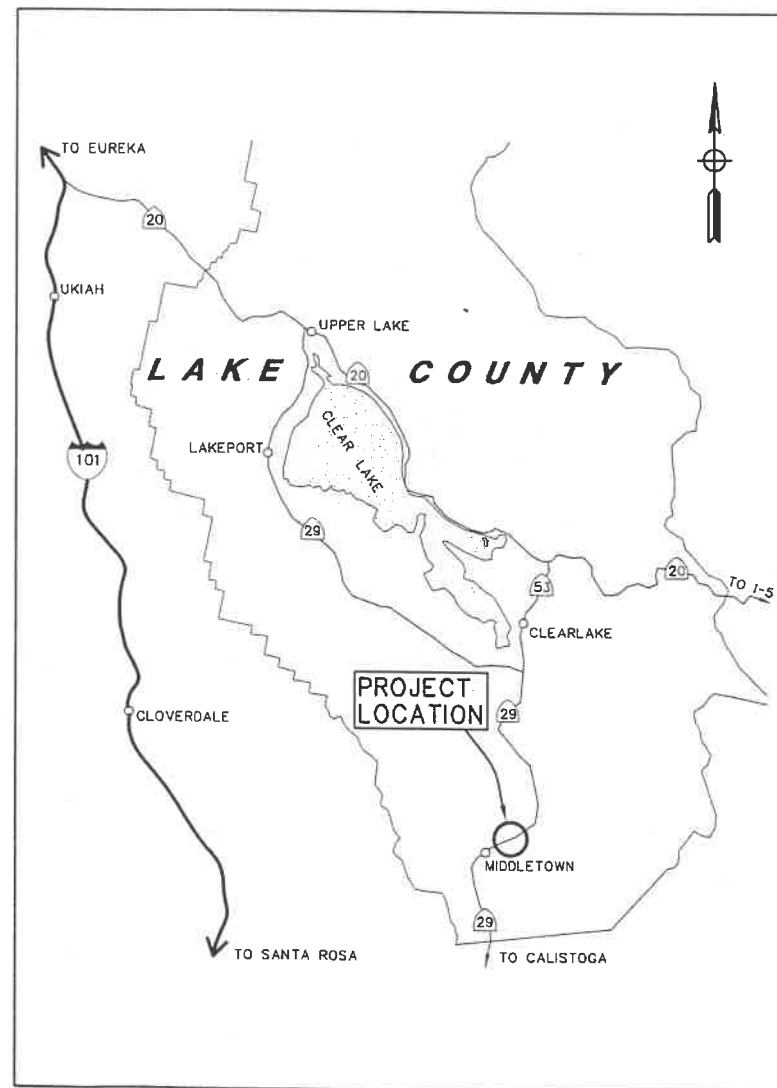

LOCATION MAP

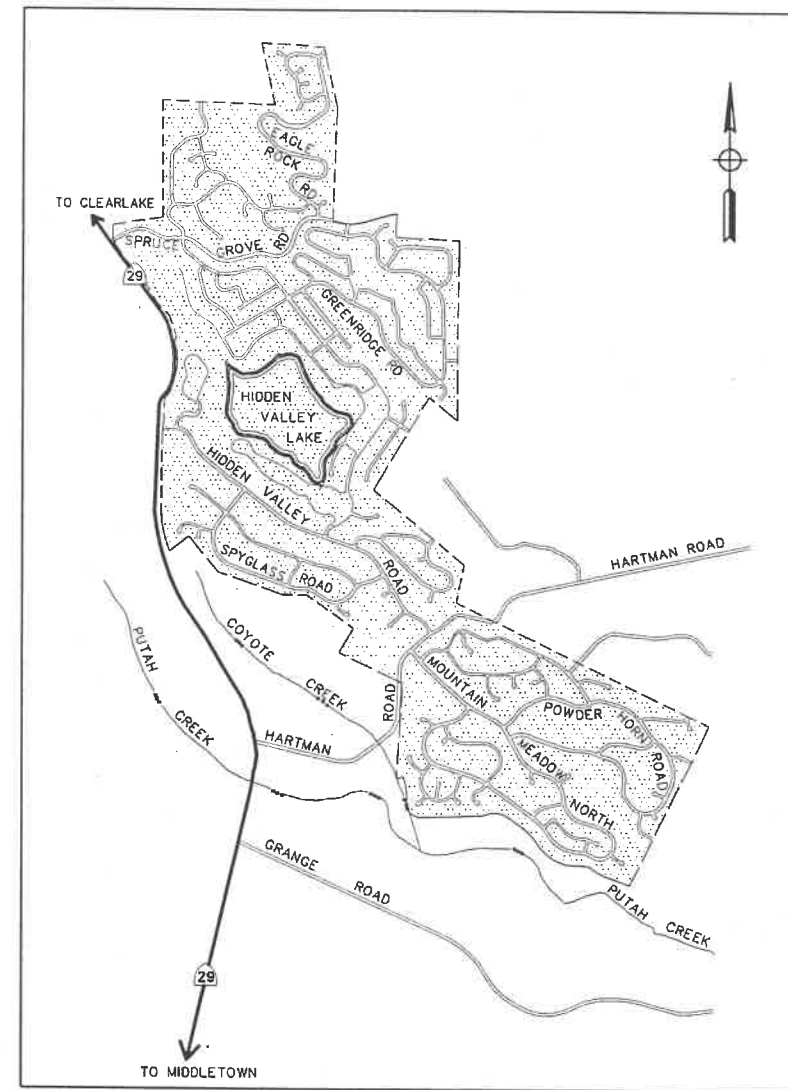

VICINITY MAP



HIDDEN VALLEY LAKE CSD

BOARD OF DIRECTORS

- C. PETKOVICH - PRESIDENT
- T. D'AGOSTA - VICE PRESIDENT
- H. FREEMAN - FINANCE OFFICER
- J. HERROD - DIRECTOR
- J. SHARPEN - DIRECTOR

PLANS AND SPECIFICATIONS APPROVED BY THE BOARD OF DIRECTORS
OF THE HIDDEN VALLEY LAKE COMMUNITY SERVICES DISTRICT, COUNTY OF LAKE,
STATE OF CALIFORNIA, THIS _____ DAY OF _____ 2003.

SIGNED: 
MEL AUST, General Manager



CONSULTANTS

BAR IS ONE INCH ON ORIGINAL DRAWING.
0 1"
IF NOT ONE INCH ON THIS SHEET, ADJUST SCALES ACCORDINGLY



PROJECT NAME

WATER SYSTEM IMPROVEMENTS SCHEDULE 3 PRV REPLACEMENTS


OWNER
HIDDEN VALLEY LAKE COMMUNITY SERVICES DISTRICT

MARK	DATE	DESCRIPTION

PROJECT NO: 02-2053-04
DRAWN BY: RJF
DESIGNED BY: JM
CHECKED BY:

SHEET TITLE
SITE PLAN & INDEX OF DRAWINGS

DRAWING NUMBER
G-002
SHEET 2 OF 8

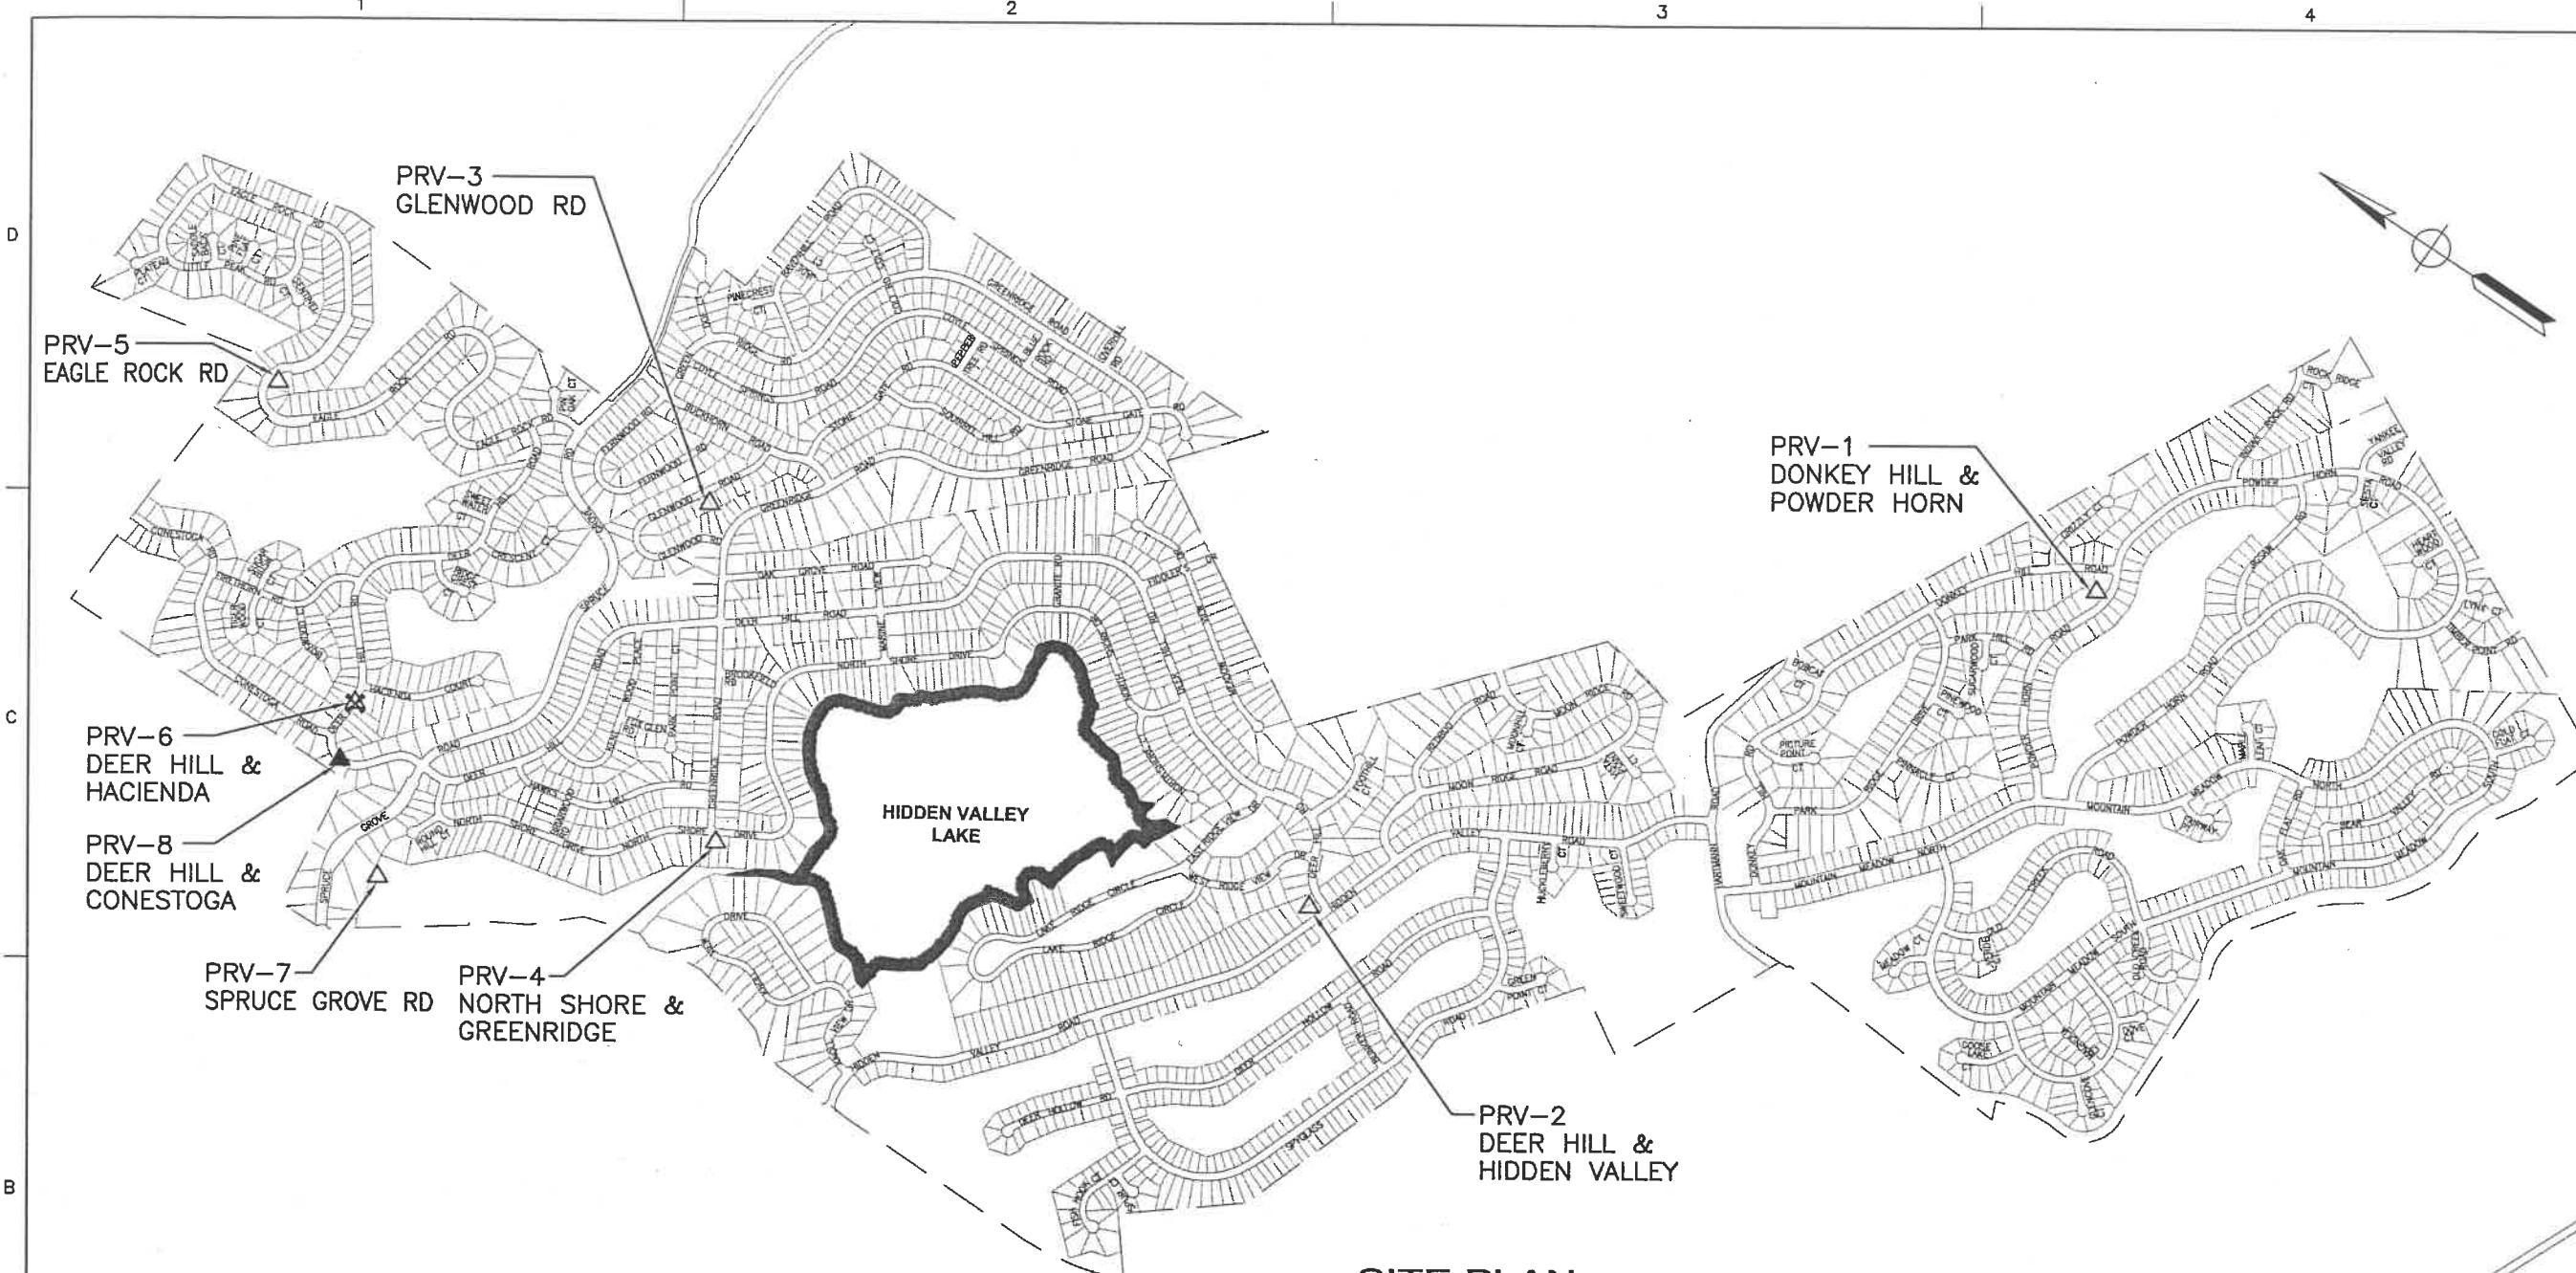

SITE PLAN
SCALE: 1"=700'

LEGEND

- △ EXISTING PRV TO BE REPLACED
- ✘ EXISTING PRV TO BE DEMOLISHED
- ▲ NEW PRV

INDEX TO SHEETS

Sht	Dwg No.	Sheet Title
GENERAL		
1.	G-001	COVER SHEET
2.	G-002	SITE PLAN & INDEX OF DRAWINGS
3.	G-003	ABBREVIATIONS, SYMBOLS & LEGEND
CIVIL		
4.	C-001	GENERAL CIVIL NOTES
5.	C-401	PRV REPLACEMENT PLANS - 1
6.	C-402	PRV REPLACEMENT PLANS - 2
7.	C-501	DETAILS - 1
8.	C-502	DETAILS - 2